



SITE NUMBER: CCL04011/CNU4011

FA NUMBER: 10147297

**LTE 1C MRSFR001479, LTE 2C MRSFR044791,
LTE 3C MRSFR044716, LTE 4C MRSFR044684,
LTE 5C MRSFR044762, LTE 6C MRSFR044755**

PTN# 3701A0DT8K, PTN# 3701A0DT4K,

PTN# 3701A0DT2R, PTN# 3701A0B1QH,

PTN# 3701A0DT7N, PTN# 3701A0DT1V

SITE NAME: CUPERTINO SPORTS CENTER

21111 STEVENS CREEK BLVD

CUPERTINO, CA 95014

ENGINEERING

2016 CALIFORNIA BUILDING CODE
2016 CALIFORNIA TITLE 24
2016 CALIFORNIA FIRE CODE
2016 CALIFORNIA ENERGY CODE
2016 CALIFORNIA MECHANICAL CODE
TIA/EIA-222-F OR LATEST EDITION

GENERAL NOTES

THE FACILITY IS UNMANNED AND NOT FOR HUMAN HABITATION. A TECHNICIAN WILL VISIT THE SITE AS REQUIRED FOR ROUTINE MAINTENANCE. THE PROJECT WILL NOT RESULT IN ANY SIGNIFICANT DISTURBANCE OR EFFECT ON DRAINAGE, NO SANITARY SEWER SERVICE, POTABLE WATER, OR TRASH DISPOSAL IS REQUIRED AND NO COMMERCIAL SIGNAGE IS PROPOSED.

SITE INFORMATION

PROPERTY OWNER: CITY OF CUPERTINO
ADDRESS: 10300 TOREE AVENUE
CUPERTINO, CA 95014

APPLICANT: AT&T
ADDRESS: 5001 EXECUTIVE PARKWAY,
SAN RAMON, CALIFORNIA 94583

LATITUDE (NAD 83): 37° 19' 25.71" N
LONGITUDE (NAD 83): 122° 02' 30.23" W
LONGITUDE/LATITUDE TYPE: NAD 83
GROUND ELEVATION: 271.6' AMSL
APN #: 326-29-022
ZONING JURISDICTION: CITY OF CUPERTINO
CURRENT ZONING: OSC - OPEN SPACE CONSERVATION
POWER COMPANY: SCE
TELCO COMPANY: VERIZON
PROPOSED USE: P, U
LEASE AREA (SF): N/A

PROJECT TEAM

PROJECT MANAGER:
VINCULUMS
575 LENNON LN # 125
WALNUT CREEK, CA 94596
CONTACT: MICHELE PHIPPEN
PH: (925) 895-3734
EMAIL: MPPHEN@VINCULUMS.COM

A/E:
INTELOCITY, LLC
1875 CORONADO AVE,
SIGNAL HILL, CALIFORNIA 90755
CONTACT: SAM VANN
PH: 562-230-3519

SITE ACQUISITION:
TSJ CONSULTING INC.
31878 DEL OBISPO ST.
STE # 118-454
SAN JUAN CAPISTRANO, CA 92675
CONTACT: TOM JOHNSON
MOBILE: (925) 785-3727

ZONING:
TSJ CONSULTING INC.
31878 DEL OBISPO ST.
STE # 118-454
SAN JUAN CAPISTRANO, CA 92675
CONTACT: TOM JOHNSON
MOBILE: (925) 785-3727

RF ENGINEER:
AT&T
5001 EXECUTIVE PARKWAY,
SAN RAMON, CALIFORNIA 94583

CONSTRUCTION MANAGER:
VINCULUMS
575 LENNON LN # 125
WALNUT CREEK, CA 94596
CONTACT: FLOYD GREEN
PH: (408) 526-1927
EMAIL: FGREEN@VINCULUMS.COM

VICINITY MAP



DRIVING DIRECTIONS

DIRECTIONS FROM AT&T OFFICE:
5001 EXECUTIVE PARKWAY, SAN RAMON, CALIFORNIA 94583, GET ON I-680 S FROM BOLLINGER CANYON RD, HEAD NORTHEAST ON BISHOP DR TOWARD SUNSET DR. TURN RIGHT ONTO SUNSET DR, USE THE RIGHT 2 LANES TO TURN RIGHT ONTO BOLLINGER CANYON RD, USE THE RIGHT LANE TO MERGE ONTO I-680 S VIA THE RAMP TO SAN JOSE. CONTINUE ON I-680 S TO CUPERTINO. TAKE THE DE ANZA BOULEVARD EXIT FROM I-280 N, MERGE ONTO I-680 S, CONTINUE STRAIGHT TO STAY ON I-680 S (SIGNS FOR I-580 W/DUBLIN/OAKLAND/SAN JOSE), CONTINUE ONTO I-280 N, USE THE 2ND FROM THE RIGHT LANE TO TAKE THE DE ANZA BOULEVARD EXIT, CONTINUE ON N DE ANZA BLVD. DRIVE TO STEVENS CREEK BLVD, USE THE LEFT 2 LANES TO TURN LEFT ONTO N DE ANZA BLVD, TURN RIGHT ONTO STEVENS CREEK BLVD, DESTINATION WILL BE ON THE RIGHT.

ZONING DRAWING

IF USING 11"x17" PLOT, DRAWINGS WILL BE HALF SCALE

PROJECT DESCRIPTION

AT&T WIRELESS PROPOSES THE INSTALLATION.

- BRING POWER/TELCO/FIBER TO SITE LOCATION.
- DEMOLISH AND REMOVE PLANTER AREA AND (1) (E) TREE FOR EQUIPMENT INSTALLATION.
- INSTALL AT&T OUTDOOR EQUIPMENT PLATFORMS & ASSOCIATED EXTERIOR EQUIPMENT.
- INSTALL MONOPINE STRUCTURE.
- INSTALL (P) 8'-0" HIGH STEEL FENCE W/HORIZONTAL WOOD PANELS AND CHAINLINK SECURITY TOPPER.
- INSTALL (16) (P) PANEL ANTENNAS (4 PER SECTOR).
- INSTALL (21) (P) RRUS (7 PER SECTOR).
- INSTALL (5) (P) DC-6 SURGE SUPPRESSORS.
- INSTALL (P) COAX JUMPER LINES FROM RRU TO (P) ANTENNAS.
- INSTALL (P) GPS UNIT, TYP. OF 2.
- INSTALL (2) 5216 INSIDE (P) CABINET.
- INSTALL (2) XMU03 WITH (4) (P) 6601 CHASSIS INSIDE (P) CABINET.

DRAWING INDEX

SHEET NO:

T-1	TITLE SHEET
C-1	TOPOGRAPHIC SURVEY
A-1	SITE PLAN
A-2	ENLARGED SITE PLAN AND EQUIPMENT PLANS
A-3	EXISTING AND PROPOSED ANTENNA LAYOUTS
A-4	ELEVATIONS
A-5	ELEVATIONS
L-1	IRRIGATION PLAN
L-2	IRRIGATION DETAILS
L-3	PLANTING PLAN

DO NOT SCALE DRAWINGS

SUBCONTRACTOR SHALL VERIFY ALL PLANS & EXISTING DIMENSIONS & CONDITIONS ON THE JOB SITE & SHALL IMMEDIATELY NOTIFY THE ENGINEER IN WRITING OF ANY DISCREPANCIES BEFORE PROCEEDING WITH THE WORK OR BE RESPONSIBLE FOR SAME.



**UNDERGROUND
SERVICE ALERT OF
NORTHERN CALIFORNIA**
800-642-2444

48 HOURS BEFORE YOU DIG



5001 EXECUTIVE PARKWAY,
SAN RAMON, CA 94583



575 Lennon Ln #125
Walnut Creek, CA 94598

PLANS PREPARED BY:

INTELOCITY
DESIGN | BUILD | INNOVATE

1875 Coronado Ave
Signal Hill, CA 90755

A NUBRIVE COMPANY

REV	DATE	DESCRIPTION	INT
4	10/23/18	ADD LANDSCAPE PLANS	SV
3	10/02/18	CLIENTS COMMENTS	BC
2	08/23/18	ADDITIONAL REDLINES	MM
1	08/13/18	100% ZONING DRAWINGS	MM
0	07/18/18	90% ZONING DRAWINGS	PDC

IT IS A VIOLATION OF LAW FOR ANY PERSON,
UNLESS THEY ARE ACTING UNDER THE DIRECTION
OF A LICENSED PROFESSIONAL ENGINEER,
TO ALTER THIS DOCUMENT.


**CCL04011/CNU4011
CUPERTINO SPORTS CENTER
21111 STEVENS CREEK BLVD
CUPERTINO, CA 95014
MONOPINE/OUTDOOR**

SHEET TITLE

TITLE SHEET

SHEET NUMBER

T-1

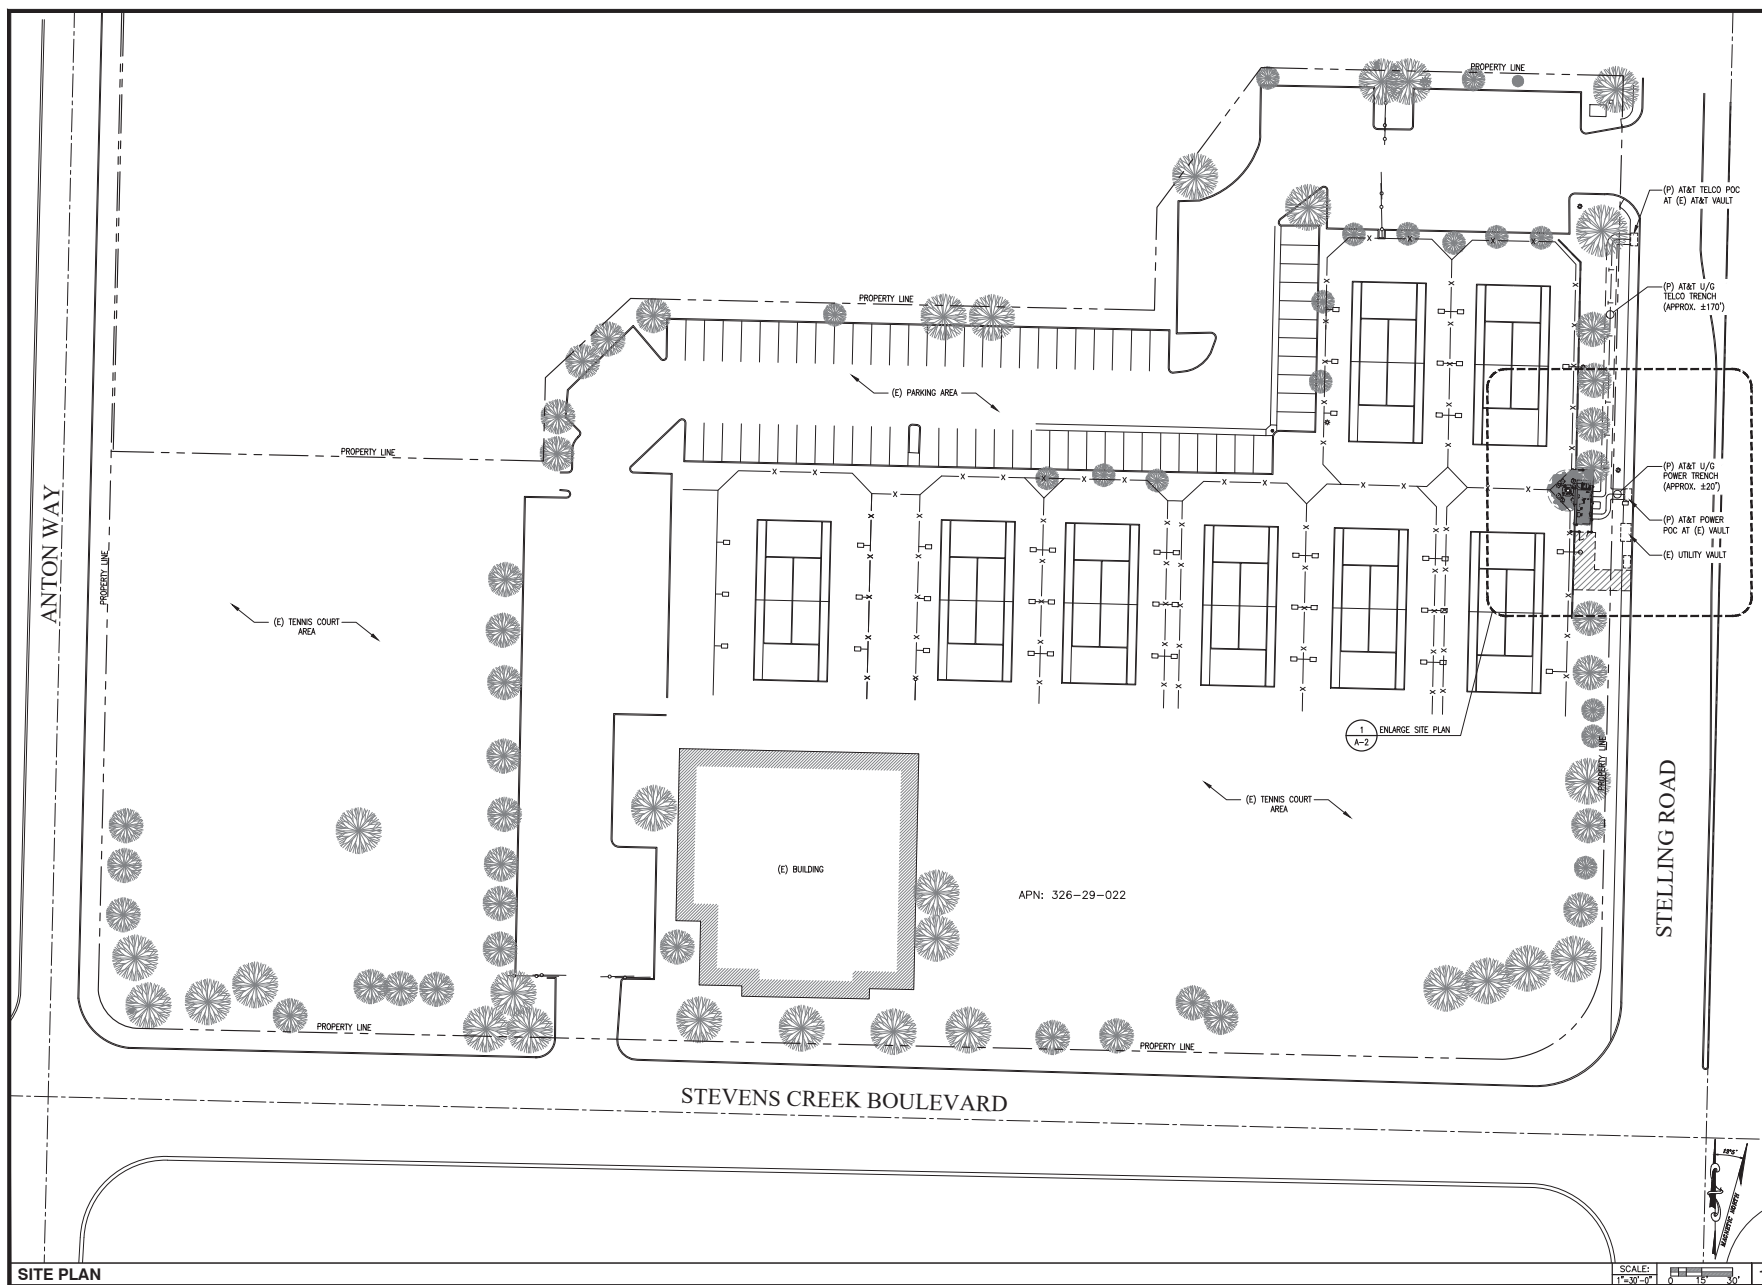

SITE PLAN

SCALE: 1" = 30' 1



5001 EXECUTIVE PARKWAY,
SAN RAMON, CA 94583



575 Lennon Ln #125
Walnut Creek, CA 94598

PLANS PREPARED BY:

INTELOCITY
DESIGN | BUILD | INNOVATE

1875 Coronado Ave
Signal Hill, CA 90755

A NURWAVE COMPANY

4	10/23/18	ADD LANDSCAPE PLANS	SV
3	10/02/18	CLIENTS COMMENTS	BC
2	08/23/18	ADDITIONAL REDLINES	MM
1	08/13/18	100% ZONING DRAWINGS	MM
0	07/18/18	90% ZONING DRAWINGS	PDC
REV	DATE	DESCRIPTION	INT

IT IS A VIOLATION OF LAW FOR ANY PERSON,
UNLESS THEY ARE ACTING UNDER THE DIRECTION
OF A LICENSED PROFESSIONAL ENGINEER,
TO ALTER THIS DOCUMENT.


CCL04011/CNU4011
CUPERTINO SPORTS CENTER
21111 STEVENS CREEK BLVD
CUPERTINO, CA 95014
MONOPINE/OUTDOOR

SHEET TITLE

SITE PLAN


SHEET NUMBER

A-1

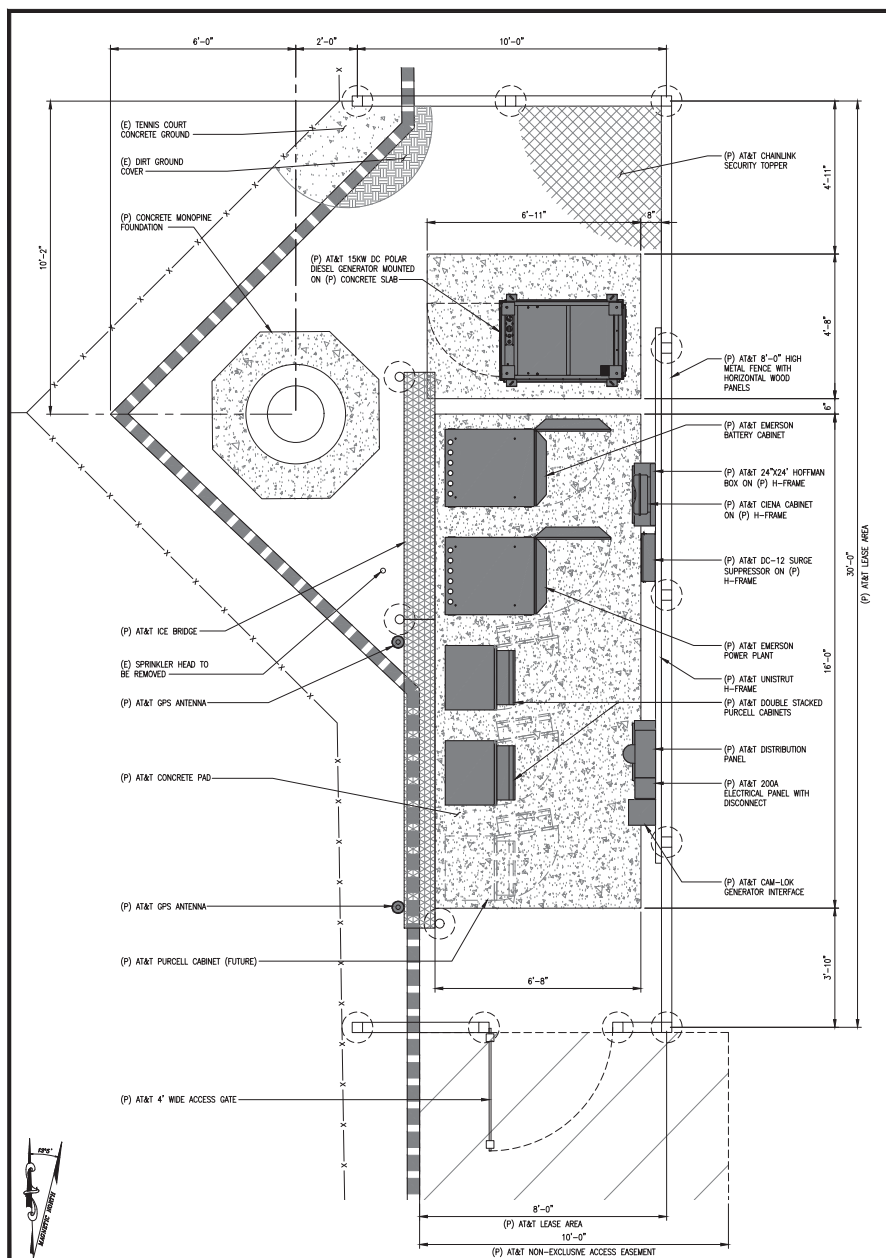

PROPOSED EQUIPMENT PLAN

(P) ANTENNA SCHEDULE													
ANTENNA POSITION	STATUS	TECHNOLOGY	RAD CENTER	ANTENNA MAKE/MODEL	AZIMUTH	ANTENNA COUNT	FILTER/TMA MODEL	FILTER/TMA COUNT	TRANSMISSION LENGTH	TRANSMISSION TYPE(S)	RRUS MAKE/MODEL	RRUS COUNT	
ALPHA SECTOR	A1	(P)	1C/2C	60'-0"	QUINTELL QS6458-S	30°	1	-	-	±180'	HYBRID	RRUS-11 E B12 RRUS-4415 B25	1
	A2	(P)	5C/6C	60'-0"	QUINTELL QS6458-S	30°	1	-	-	±180'		RRUS-4478 B5 RRUS-4426 B66	1
	A3	(P)	FNET/4C	60'-0"	QUINTELL QS6458-S	30°	1	-	-	±180'		RRUS-E2 B29 RRUS-32	1
	A4	(P)	850/3C	60'-0"	QUINTELL QS6458-S	30°	1	-	1	±180'		-	-
BETA SECTOR	B1	(P)	1C/2C	60'-0"	QUINTELL QS6458-S	310°	1	-	-	±180'	HYBRID	RRUS-11 E B12 RRUS-4415 B25	1
	B2	(P)	5C/6C	60'-0"	QUINTELL QS6458-S	310°	1	-	-	±180'		RRUS-4478 B5 RRUS-4426 B66	1
	B3	(P)	FNET/4C	60'-0"	QUINTELL QS6458-S	310°	1	-	-	±180'		RRUS-E2 B29 RRUS-32	1
	B4	(P)	850/3C	60'-0"	QUINTELL QS6458-S	310°	1	-	1	±180'		-	-
GAMMA SECTOR	C1	(P)	1C/2C	60'-0"	QUINTELL QS6458-S	215°	1	-	-	±180'	HYBRID	RRUS-11 E B12 RRUS-4415 B25	1
	C2	(P)	5C/6C	60'-0"	QUINTELL QS6458-S	215°	1	-	-	±180'		RRUS-4478 B5 RRUS-4426 B66	1
	C3	(P)	FNET/4C	60'-0"	QUINTELL QS6458-S	215°	1	-	-	±180'		RRUS-E2 B29 RRUS-32	1
	C4	(P)	850/3C	60'-0"	QUINTELL QS6458-S	215°	1	-	1	±180'		-	-
DELTA SECTOR	D1	(P)	1C/2C	60'-0"	QUINTELL QS6458-S	145°	1	-	-	±180'	HYBRID	RRUS-11 E B12 RRUS-4415 B25	1
	D2	(P)	5C/6C	60'-0"	QUINTELL QS6458-S	145°	1	-	-	±180'		RRUS-4478 B5 RRUS-4426 B66	1
	D3	(P)	FNET/4C	60'-0"	QUINTELL QS6458-S	145°	1	-	-	±180'		RRUS-E2 B29 RRUS-32	1
	D4	(P)	850/3C	60'-0"	QUINTELL QS6458-S	145°	1	-	1	±180'		-	-
TOTAL												24	

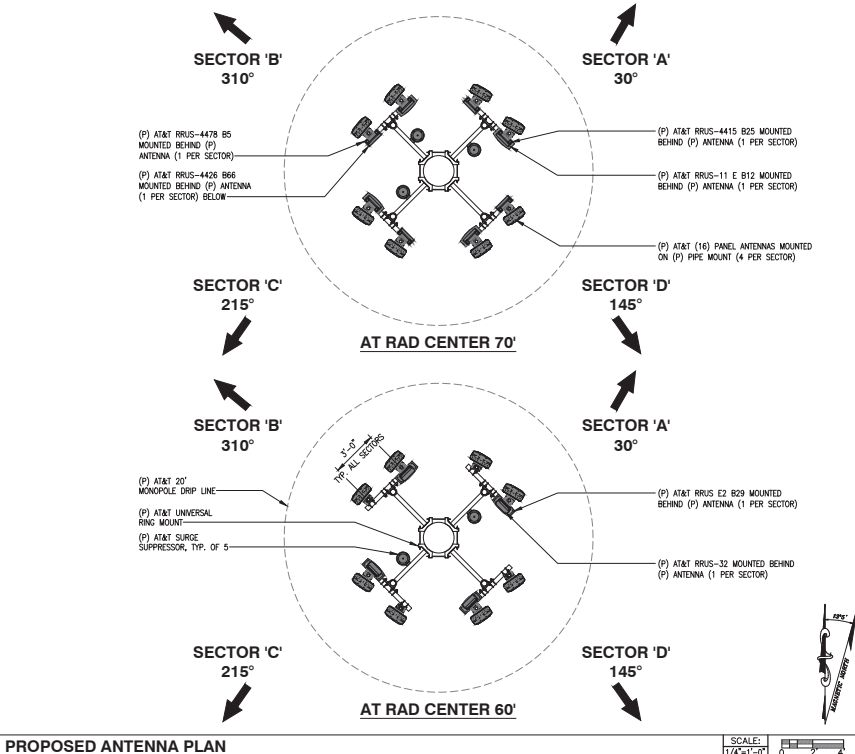

PROPOSED ANTENNA PLAN



5001 EXECUTIVE PARKWAY,
SAN RAMON, CA 94583



575 Lennon Ln #125
Walnut Creek, CA 94598

PLANS PREPARED BY:

INTELOCITY
DESIGN | BUILD | INNOVATE

1875 Coronado Ave
Signal Hill, CA 90755

A NURAVE COMPANY

REV	DATE	DESCRIPTION	INT
4	10/23/18	ADD LANDSCAPE PLANS	SV
3	10/02/18	CLIENTS COMMENTS	BC
2	08/23/18	ADDITIONAL REDLINES	MM
1	08/13/18	100% ZONING DRAWINGS	MM
0	07/18/18	90% ZONING DRAWINGS	PDC

IT IS A VIOLATION OF LAW FOR ANY PERSON,
UNLESS THEY ARE ACTING UNDER THE DIRECTION
OF A LICENSED PROFESSIONAL ENGINEER,
TO ALTER THIS DOCUMENT.


CCL04011/CNU4011
CUPERTINO SPORTS CENTER
21111 STEVENS CREEK BLVD
CUPERTINO, CA 95014
MONOPINE/OUTDOOR

SHEET TITLE
EQUIPMENT/ANTENNA PLAN
ANTENNA/RRU SCHEDULES

SHEET NUMBER

A-3

NOTE:
 • CONTRACTOR TO PAINT ALL (P) ANTENNAS, RRUS, AND ASSOCIATED EQUIPMENT TO MATCH EXISTING CONDITIONS.
 • ADD ANTENNA NEEDLE SOCKS.

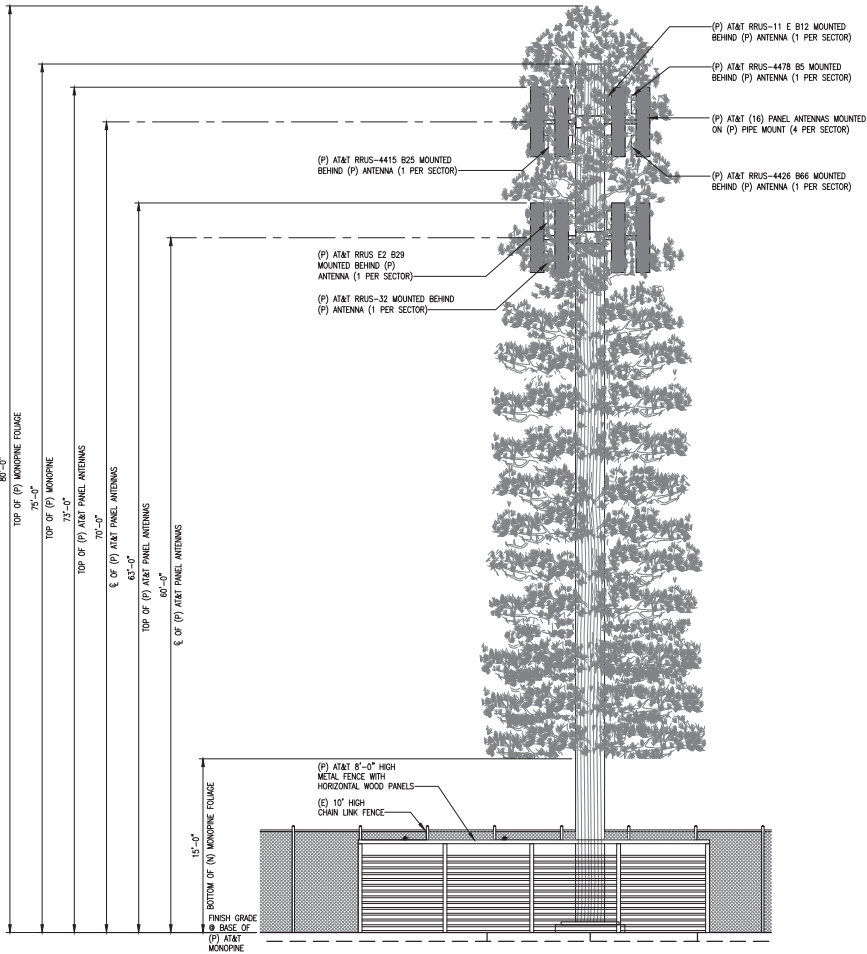


EAST ELEVATION

SCALE: 3/16"=1'-0"

2

NOTE:
 • CONTRACTOR TO PAINT ALL (P) ANTENNAS, RRUS, AND ASSOCIATED EQUIPMENT TO MATCH EXISTING CONDITIONS.
 • ADD ANTENNA NEEDLE SOCKS.

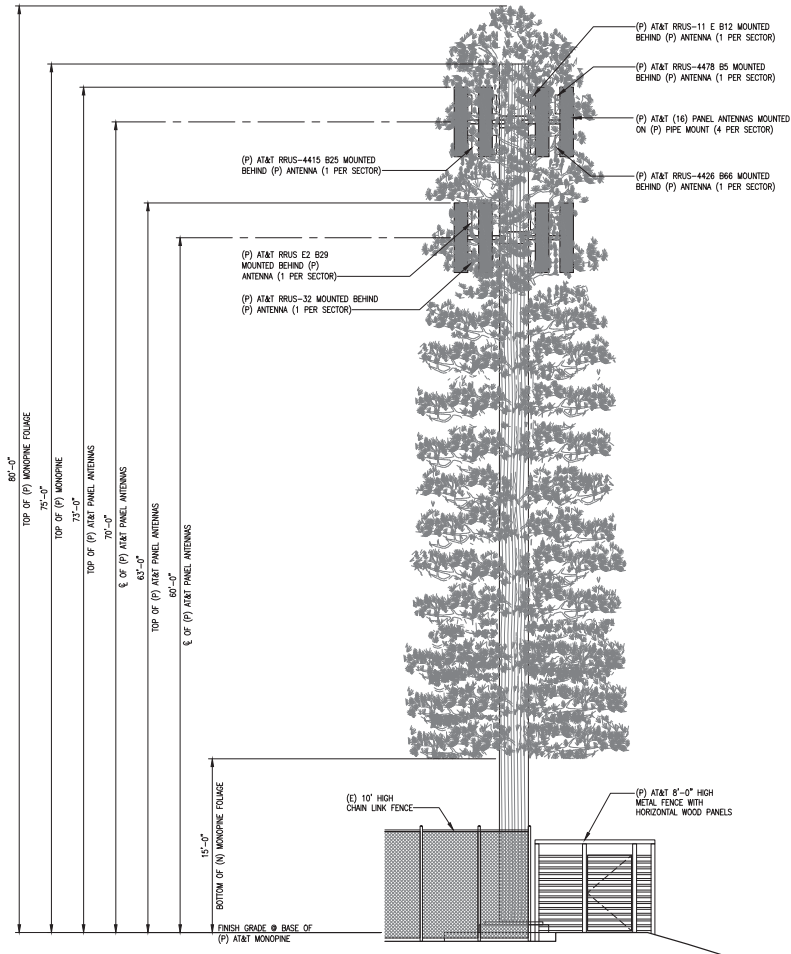

SOUTH ELEVATION

SCALE: 3/16"=1'-0"

1



5001 EXECUTIVE PARKWAY,
 SAN RAMON, CA 94583



575 Lennon Ln #125
 Walnut Creek, CA 94598

PLANS PREPARED BY:

INTELOCITY
 DESIGN | BUILD | INNOVATE

1875 Coronado Ave
 Signal Hill, CA 90755

A NUBRIVE COMPANY

REV	DATE	DESCRIPTION	INT
4	10/23/18	ADD LANDSCAPE PLANS	SV
3	10/02/18	CLIENTS COMMENTS	BC
2	08/23/18	ADDITIONAL REDLINES	MM
1	08/13/18	100% ZONING DRAWINGS	MM
0	07/18/18	90% ZONING DRAWINGS	PDC

IT IS A VIOLATION OF LAW FOR ANY PERSON, UNLESS THEY ARE ACTING UNDER THE DIRECTION OF A LICENSED PROFESSIONAL ENGINEER, TO ALTER THIS DOCUMENT.

CCL04011/CNU4011
 CUPERTINO SPORTS CENTER
 21111 STEVENS CREEK BLVD
 CUPERTINO, CA 95014
 MONOPINE/OUTDOOR


SHEET TITLE

ELEVATIONS

SHEET NUMBER

A-4

NOTE:
 • CONTRACTOR TO PAINT ALL (P) ANTENNAS, RRUS, AND ASSOCIATED EQUIPMENT TO MATCH EXISTING CONDITIONS.
 • ADD ANTENNA NEEDLE SOCKS.

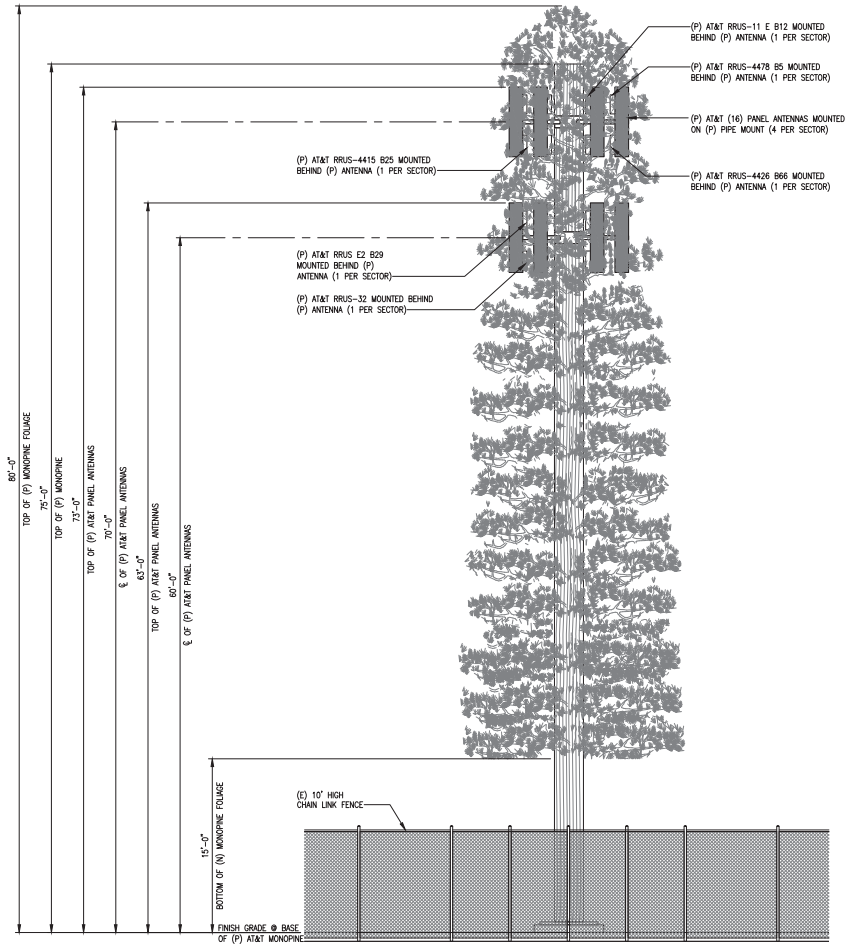


WEST ELEVATION

SCALE: 1/8"=1'-0"

2

NOTE:
 • CONTRACTOR TO PAINT ALL (P) ANTENNAS, RRUS, AND ASSOCIATED EQUIPMENT TO MATCH EXISTING CONDITIONS.
 • ADD ANTENNA NEEDLE SOCKS.

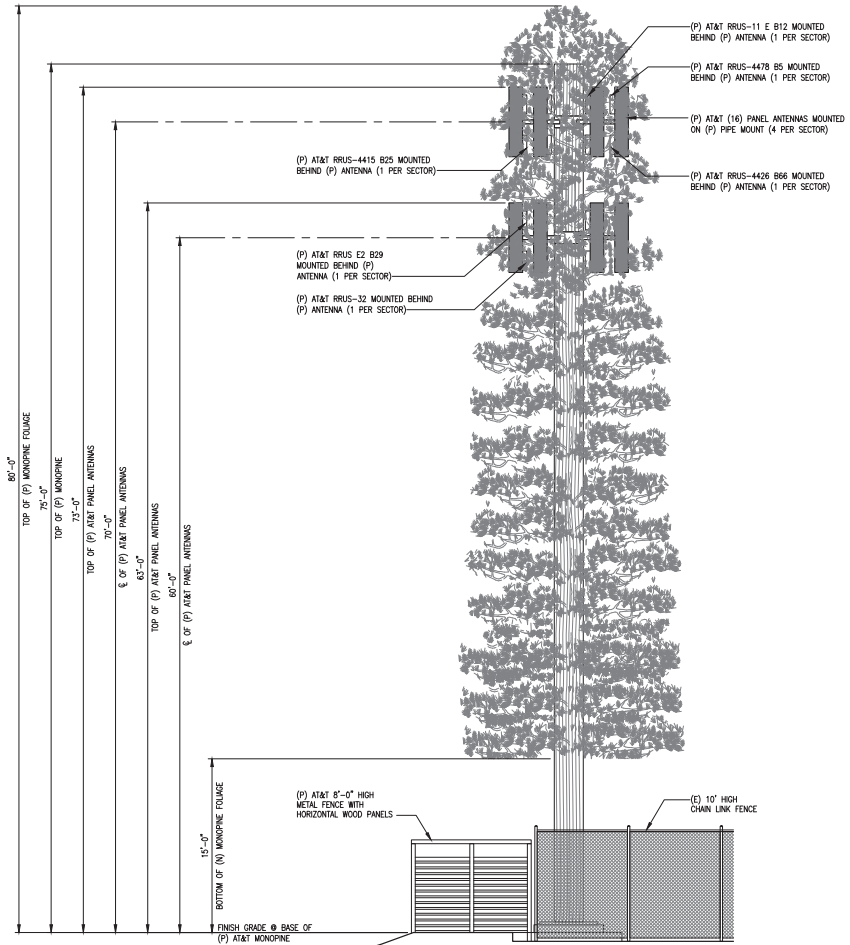

NORTH ELEVATION

SCALE: 1/8"=1'-0"

1



5001 EXECUTIVE PARKWAY,
 SAN RAMON, CA 94583



575 Lennon Ln #125
 Walnut Creek, CA 94598

PLANS PREPARED BY:

INTELOCITY
 DESIGN | BUILD | INNOVATE

1875 Coronado Ave
 Signal Hill, CA 90755

A NUBRIVE COMPANY

4	10/23/18	ADD LANDSCAPE PLANS	SV
3	10/02/18	CLIENTS COMMENTS	BC
2	08/23/18	ADDITIONAL REDLINES	MM
1	08/13/18	100% ZONING DRAWINGS	MM
0	07/18/18	90% ZONING DRAWINGS	PDC
REV	DATE	DESCRIPTION	INT

IT IS A VIOLATION OF LAW FOR ANY PERSON, UNLESS THEY ARE ACTING UNDER THE DIRECTION OF A LICENSED PROFESSIONAL ENGINEER, TO ALTER THIS DOCUMENT.

CCL04011/CNU4011
 CUPERTINO SPORTS CENTER
 21111 STEVENS CREEK BLVD
 CUPERTINO, CA 95014
 MONOPINE/OUTDOOR

SHEET TITLE

ELEVATIONS

SHEET NUMBER

A-5

Irrigation Legend

Symbol	Catalogue No.	Manuf.	Description	GPM	PSI	Detail No.
	1402	RAINBIRD	6" FULL CIRCLE BUBBLER	1.0	30	A, SHEET L-3
	NIBCO	NIBCO	BALL VALVE			B, SHEET L-3
	PCA SERIES	RAINBIRD	REMOTE CONTROL VALVE	1"	SET 30PSI	C, SHEET L-3
	ESP-SMT4	RAINBIRD	4-STATION OUTDOOR			D, SHEET L-3
	RAIN CLIK	HUNTER	RAIN SENSOR			

Schedule 40 PVC Pipe @ 18" Min. Depth (3/4" Diameter Unless Otherwise Indicated)

Maximum Flow (GPM) Through Valve
 Controller Station
 Valve Size

IRRIGATION NOTES

1. ALL IRRIGATION SYSTEMS SHALL BE DESIGNED TO PREVENT RUNOFF, OVER-SPRAY, LOW-HEAD DRAINAGE AND OTHER SIMILAR CONDITIONS. SOIL TYPES AND INFILTRATION RATES SHALL BE CONSIDERED WHEN DESIGNING IRRIGATION SYSTEMS. IRRIGATION SYSTEM SHALL BE DESIGNED, CONSTRUCTED, MANAGED, AND MAINTAINED TO ACHIEVE AS HIGH AN OVERALL EFFICIENCY AS POSSIBLE.
2. ALL IRRIGATION SYSTEMS SHALL INCLUDE:
 - A. A SMART IRRIGATION CONTROLLER, OR OTHER EQUIVALENT TECHNOLOGY WHICH AUTOMATICALLY ADJUSTS THE FREQUENCY AND / OR DURATION OF IRRIGATION EVENTS IN RESPONSE TO CHANGING WEATHER CONDITIONS, SHALL BE REQUIRED.
 - B. ANTI-DRAIN CHECK VALVES SHALL BE INSTALLED TO PREVENT LOW-HEAD DRAINAGE IN SPRINKLER HEADS.
 - C. A PRESSURE REGULATOR WHEN THE STATIC WATER PRESSURE EXCEED MAXIMUM RECOMMENDED OPERATION PRESSURE OF THE IRRIGATION SYSTEM.
 - D. A RAIN SENSOR WITH AN AUTOMATIC RAIN SHUTOFF FEATURE SHALL BE REQUIRED.

INSPECTION NOTES

1. PRIOR TO START OF WORK, THE CONTRACTOR AND OWNER'S REPRESENTATIVE SHALL MEET AND REVIEW UTILITIES AND EXISTING SITE CONDITIONS. AT COMPLETION OF WORK, FINAL INSPECTION SHALL BE MADE AND ACCEPTED BY OWNER AND GOVERNING JURISDICTION.
2. THIS PLAN IS DIAGNOSTIC AND ALLOWS FOR ADJUSTMENT TO BE MADE TO ACCOMMODATE EXISTING SITE CONDITIONS.
3. LANDSCAPE INSTALLATION SHALL MEET STANDARD SHOWN UNLESS SUPERSEDED BY LOCAL STANDARDS.
4. PRECAUTIONS SHALL BE TAKEN TO PROTECT ALL UTILITIES, STRUCTURES ON SITE. THE CONTRACTOR IS RESPONSIBLE FOR DAMAGES AND REPLACEMENT.
5. THE CONTRACTOR SHALL REMOVE ALL DEBRIS, WEEDS AND TRASH FROM COMMUNICATION SITE AREA AT COMPLETION OF WORK.
6. CONTRACTOR TO MAINTAIN SITE FOR 90 DAYS.
7. THE MAINTENANCE OF THE COMMUNICATION SITE IS DEFINED WITHIN MAINTENANCE AGREEMENT WITH OWNER.

P.D.C.

CONTRACTOR TO CONNECT TO EXISTING IRRIGATION AT LOCATION OF EXISTING CONTROLLER VALVES. IF DAMAGED, CONTRACTOR TO REPLACE EXISTING VALVE WITH NEW. CONTRACTOR TO INSPECT ALL MAINLINE AND LATERAL LINES AND REPLACE IF DAMAGED OR WORN. IF DAMAGED CONTRACTOR TO REPLACE SPRAYHEADS AT LOCATION WITH NEW HEADS. CONTRACTOR TO ADD NEW SMART CONTROLLER WITH RAIN-CLIK (PER NOTES, THIS PAGE).

EXISTING IRRIGATION NOTES

1. ALL IRRIGATION DAMAGED DURING CONSTRUCTION OF ENCLOSURE WALLS SHALL BE REPLACED AND CONSISTENT WITH EXISTING IRRIGATION MATERIALS.

LANDSCAPE CONTRACTOR NOTES

1. LANDSCAPE CONTRACTOR MUST TO INSTALL PROPOSED LANDSCAPING SHALL BE C-21 CERTIFIED.

IRRIGATION DETAIL NOTES

1. APPLY TEFLON TAPE TO ALL THREADED PIPE CONNECTIONS.

CHECK VALVE NOTES


1. CONTRACTOR TO UTILIZE CHECK VALVES TO PREVENT LOW-HEAD DRAINAGE.

MAINTENANCE NOTE

LANDSCAPE TO BE PROPERLY MAINTAINED IN A HEALTHY CONDITION FREE OF WEEDS, PESTS OR DISEASES. MAINTENANCE RESPONSIBILITY TO BE NEGOTIATED BETWEEN PROPERTY OWNER AND AT&T.

DIG-ALERT NOTE

1. CONTRACTOR SHALL NOTIFY UNDERGROUND SERVICE ALERT BEFORE START OF CONSTRUCTION (2 WORKING DAYS OR 48 HOURS). CONTRACTOR SHALL VERIFY EXISTING LOCATION OF UTILITIES AS NECESSARY TO IDENTIFY LOCATION.

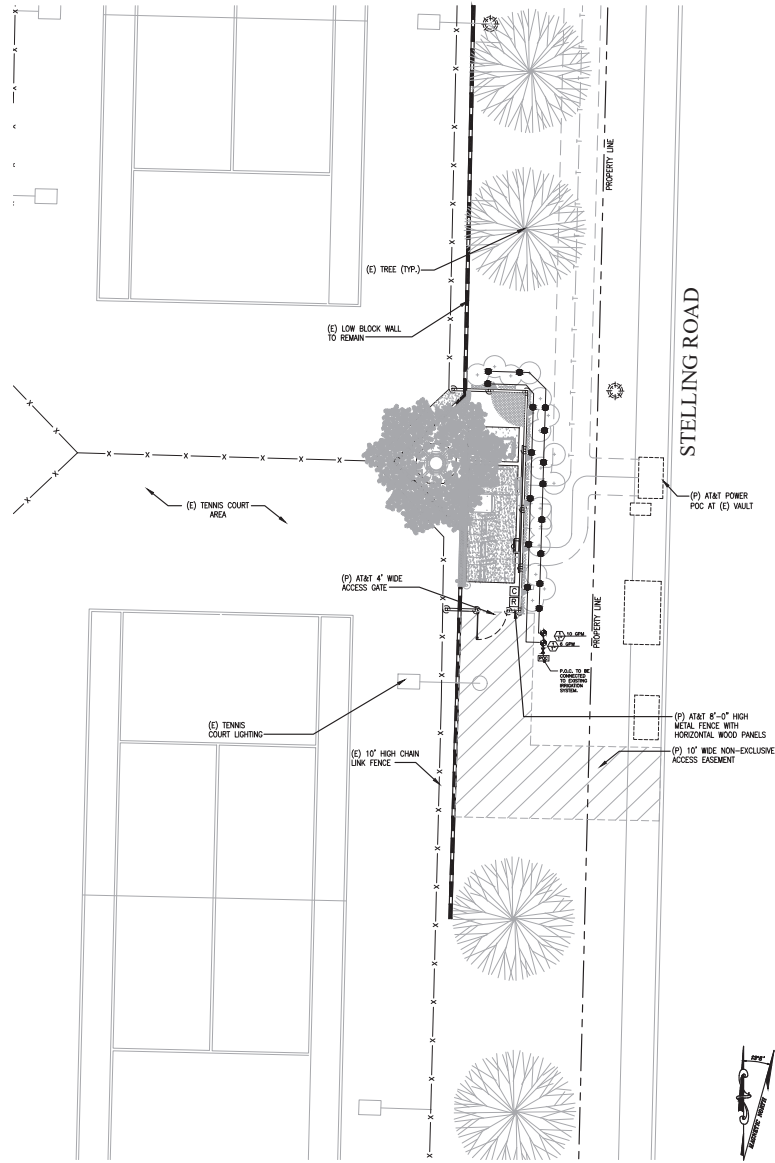

SCALE: 1/8\"=1'-0"



5001 EXECUTIVE PARKWAY,
SAN RAMON, CA 94583



575 Lennon Ln #125
Walnut Creek, CA 94598

PLANS PREPARED BY:



1875 Coronado Ave
Signal Hill, CA 90755

A NUNAVUE COMPANY

REV	DATE	DESCRIPTION	INT
3	10/02/18	CLIENTS COMMENTS	BC
2	08/23/18	ADDITIONAL REDLINES	MM
1	08/13/18	100% ZONING DRAWINGS	MM
0	07/18/18	90% ZONING DRAWINGS	PDC



CS DG
CS Design Group, Inc.
6965 El Camino Real
Suite 105-482
Carlsbad, CA 92009
(P) 760-272-5742
(F) 760-454-3097


IT IS A VIOLATION OF LAW FOR ANY PERSON, UNLESS THEY ARE ACTING UNDER THE DIRECTION OF A LICENSED PROFESSIONAL ENGINEER, TO ALTER THIS DOCUMENT.

CCL04011/CNU4011
CUPERTINO SPORTS CENTER
21111 STEVENS CREEK BLVD
CUPERTINO, CA 95014
MONOPINE/OUTDOOR

SHEET TITLE
IRRIGATION PLAN


SHEET NUMBER
L-1

IRRIGATION PLAN

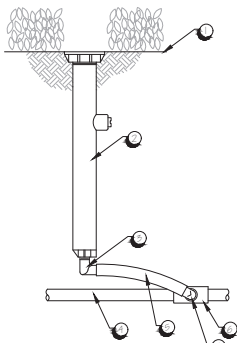

- 1 FINISH GRADE / TOP OF MULCH
- 2 POP-UP SPRAY SPRINKLER
REFER TO IRRIGATION LEGEND
- 3 1/2-INCH MALE NPT x .490 INCH
BARB ELBOW (RAIN BIRD
MODEL 38E-10S-O)
- 4 PVC LATERAL PIPE
- 5 SWING PIPE, 12-INCH LENGTH
RAIN BIRD MODEL 38-1000
- 6 PVC SCH 40 TEE OR BELL


A POP-UP SPRAY SPRINKLER
N.T.S.

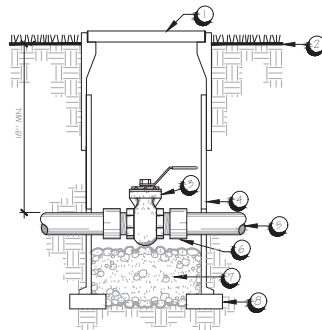

- 1 9" DIAMETER ROUND GREEN
PLASTIC VALVE BOX W/ G.V.
BURNED INTO LID (MIN. 2" HIGH)
- 2 FINISH GRADE
- 3 BALL VALVE, LINE SIZE
- 4 VALVE BOX EXTENSION, LENGTH
AS REQUIRED
- 5 PVC MAINLINE
- 6 PVC MALE ADAPTER
- 7 3/4" PEA GRAVEL
- 8 BRICK SUPPORTS

NOTE: UTILIZE PURPLE VALVE
BOXES FOR RECLAIMED
LINES

B BRASS BALL VALVE
N.T.S.

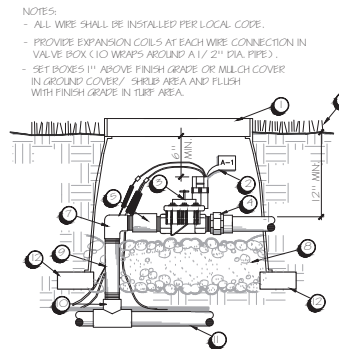


- NOTES:
- ALL WIRE SHALL BE INSTALLED PER LOCAL CODE.
 - PROVIDE EXPANSION COILS AT EACH WIRE CONNECTION IN
VALVE BOX (10 WRAPS AROUND A 1/2" DIA. PIPE).
 - SET BOXES 1" ABOVE FINISH GRADE OR MULCH COVER
IN GROUND COVER/ SHRUB AREA AND FLUSH
WITH FINISH GRADE IN TURF AREA.

- 1 AMETEK GREEN PLASTIC
VALVE BOX W/ GREEN
LOOKING COVER OR EQUAL
AND "RAN" BURNED INTO
LID (MIN. 2" HIGH)
- 2 CHERRY LID, TAG, NUMBERED
TO MATCH PLANS
- 3 CONTROL VALVE
- 4 PVC UNION
- 5 PVC SCH. 80 NIPPLE (TYP.)
- 6 FINISH GRADE, COMPACT SOIL
AROUND VALVE BOX
- 7 PVC SCH 40 S AND T ELL
- 8 3/4" PEA GRAVEL
- 9 PVC SCH. 40-1120 PIPE
- 10 PVC SLIP FITTING
- 11 PVC MAINLINE
- 12 BRICK SUPPORTS


C REMOTE CONTROL VALVE
N.T.S. B.G. STANDARD

NOTE: ALL ELECTRICAL WORK SHALL COMPLY W/ LOCAL AND NATIONAL CODES.
ELECTRICAL METER TO BE INSTALLED OPPOSITE SIDE IRRIGATION
CONTROLLER PER MFG.'S SPECIFICATIONS.

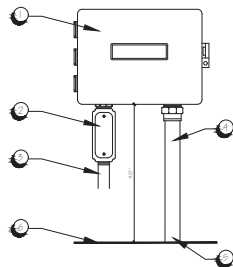

- 1 IRRIGATION CONTROLLER MOUNTED TO WALL.
REFER TO IRRIGATION LEGEND, SHEET L-1
FOR CONTROLLER SPECIFICATIONS.
- 2 JUNCTION BOX BY GENERAL CONTRACTOR.
- 3 110V WIRE AND CONDUIT TO ELECTRICAL CONNECTION
BY GENERAL CONTRACTOR.
- 4 2" CONDUIT AT MINIMUM 18" BELOW GRADE AND
INSTALL TO 5" ON OUTSIDE WALL.
- 5 CONTROL WIRES TO REMOTE CONTROLLER VIA
MAINLINE TRENCH.
- 6 FINISH GRADE.

D WALL MOUNTED CONTROLLER
N.T.S.

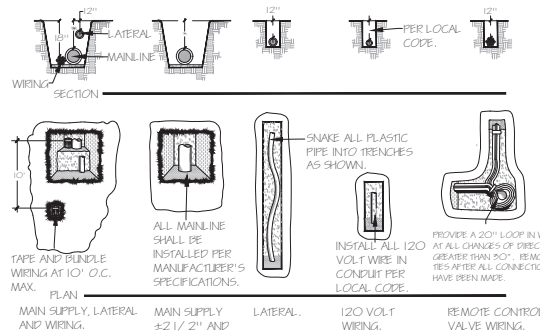

- 1 TAPES AND BUNDLE
WIRING AT 10" O.C.
MAX.
- 2 MAIN SUPPLY, LATERAL
AND WIRING.
- 3 MAIN SUPPLY
3/2 1/2" AND
SMALLER, 18"
- 4 LATERAL,
3" AND LARGER, 24"
- 5 120 VOLT
WIRING.
- 6 REMOTE CONTROL
VALVE WIRING.

E PIPE & WIRE TRENCHING DETAIL
N.T.S.



5001 EXECUTIVE PARKWAY,
SAN RAMON, CA 94583



575 Lennon Ln #125
Walnut Creek, CA 94598

PLANS PREPARED BY:

INTELOCITY
DESIGN | BUILD | INNOVATE

1875 Coronado Ave
Signal Hill, CA 90755

A NUNAVUE COMPANY

REV	DATE	DESCRIPTION	INT
3	10/02/18	CLIENTS COMMENTS	BC
2	08/23/18	ADDITIONAL REDLINES	MM
1	08/13/18	100% ZONING DRAWINGS	MM
0	07/18/18	90% ZONING DRAWINGS	PDC



**CS
DG**
6965 El Camino Real
Suite 105-482
Carlsbad, CA 92009
(P) 760-272-5742
(F) 760-454-3097

CS Design Group, Inc.

IT IS A VIOLATION OF LAW FOR ANY PERSON,
UNLESS THEY ARE ACTING UNDER THE DIRECTION
OF A LICENSED PROFESSIONAL ENGINEER,
TO ALTER THIS DOCUMENT.

CCL04011/CNU4011
CUPERTINO SPORTS CENTER
21111 STEVENS GREEK BLVD
CUPERTINO, CA 95014
MONOPINE/OUTDOOR

SHEET TITLE
IRRIGATION DETAILS

SHEET NUMBER

L-2

SYMBOL	BOTANICAL NAME	COMMON NAME	CONTAINER SIZE	QUANTITY
	<u>EXISTING TREES</u> EXISTING TREES TO REMAIN.			
	- EXISTING TREE TO BE REMOVED.			
	<u>PROPOSED SHRUBS</u>			
PIT TOB	Pittosporum t. 'Wheeters Dwarf'	Dwarf Pittosporum	5 Gal	9
RHA IND	Rhaptolepis t. 'Springtime'	Indian Hawthorne	5 Gal	6
	<u>PROPOSED VINES</u>			
	Clematis lasiantha	Chaparral Clematis	15 Gal	6

ALL EXISTING TREES WITHIN THE PROPERTY LINES SHALL BE PROTECTED IN PLACE. NO TREES SHALL BE REMOVED AS A PART OF THIS PROJECT UNLESS OTHERWISE INDICATED. LANDSCAPE CONTRACTOR TO VERIFY EXISTING TREES AT LOCATION OF PROPOSED ENCLOSURE AND ANTENNAS. IF EXISTING TREES (INDICATED TO REMAIN) ARE REMOVED OR DAMAGED DURING CONSTRUCTION OF ENCLOSURE AND INSTALLATION OF ANTENNA, CONTRACTOR TO REPLACE WITH LIKE SPECIES.

ALL FERTILIZERS AND AMENDMENTS USED DURING PLANTING PRACTICES SHALL BE DERIVED FROM ORGANIC-BASED MATERIALS AS A BEST MANAGEMENT PRACTICE FOR STREAM WATER SOURCE CONTROL. NO SEWAGE SLUDGE IS ALLOWED.

A 5" DEEP LAYER OF APPROVED ORGANIC MULCH SHALL BE APPLIED TO COVER THE SOIL WITHIN 50' OF THE MONO-TREE ON THE SUBJECT PROPERTY AFTER THE PLANTING IS COMPLETE.

1. CONTRACTOR SHALL NOTIFY UNDERGROUND SERVICE ALERT BEFORE START OF CONSTRUCTION (2 WORKING DAYS OR 48 HOURS) . CONTRACTOR SHALL VERIFY EXISTING LOCATION OF UTILITIES AS NECESSARY TO IDENTIFY LOCATION.

THE SCOPE OF WORK INCLUDES FURNISHING ALL MATERIALS NECESSARY FOR THE INSTALLATION OF THE PLANTING BACKFILL, IRRIGATION AND DRAINAGE WORK OUTLINED IN THESE DRAWINGS. ALL WORK SHALL BE PERFORMED BY PERSONS FAMILIAR WITH PLANTING WORK AND UNDER SUPERVISION OF A QUALIFIED PERSONNEL.

2. PLANT MATERIALS SPECIES ARE DIAGRAMMATIC AND MAY BE SUBJECT TO CHANGE BY THE LANDSCAPE ARCHITECT BEFORE THE MAINTENANCE PERIOD BEGINS.

3. BEFORE ANY PLANTING OCCURS, ALL PLANTED AREAS ARE TO HAVE BEEN GRIPPED IN AN ACCEPTABLE MANNER TO ASSURE FUTURE PROXIMATE PAVING FOR THE GROWING NOTES.

4. ALL PLANTING AREAS SHALL HAVE THE FOLLOWING SOIL AMENDMENTS INCORPORATED INTO THE TOP 6" OF WHOLE SOIL:

- 5. CLINIC VENTS - NITROGEN AND BORN FORMED ORGANIC AMENDMENT
- 50 LBS/6' - 6" - 20" ZORGANIC GROW-POWER FERTILIZER

5. DRAINAGE: DIPS 2 TIMES THE HEIGHT AND WIDTH OF THE FOOTCURL, BACKFILL WITH 100% NATIVE ON SITE SOIL.

6. ALL PLANTING AREAS SHALL BE EQUIVALENT SHADINGS OR EQUIVALENT.

SAMPLE BACKFILL:

- 70% NATIVE SOIL BY VOLUME
- 30% NITROCELTZ SHADINGS OR EQUIVALENT
- 16 LBS GROW-POWER PLUS PER CUBIC YARD MIX
- * OTHER AMENDMENTS PER SOIL ANALYSIS

6. IF APPLICABLE, ALL TREES TO BE SITED AS SHOWN IN THE TREE PLANTING DETAIL.

7. WHERE CIRCUMSTANCES PERMIT, PLANT NO TREE CLOSER THAN 10" TO AN EDGE OF PAVING OR HARDSHIP.



8. REFER TO PLANTING DETAILS.

9. USE PLANT MATERIALS ACCORDING TO THE AREA.


10. WHERE CIRCUMSTANCES PERMIT, DO NOT PLANT SPECIES TREES CLOSER THAN 4'-0" FROM THE EDGE OF PAVING, HARDSHIP, OR FOOT LANE. DEEPROOT OR APPROVED ROOT BARRIERS ARE TO BE INSTALLED PER DETAIL. REFER TO PLANTING LEGEND FOR SPECIES REQUIRING DEEP ROOT BARRIERS.

11. WARNING: PLANT MATERIAL LISTED MAY NOT BE CURRENTLY BEING APPROVED BY THE AGRICULTURAL COMMISSIONER'S OFFICE. LANDSCAPE CONTRACTOR IS TO CONTACT THE DEVELOPER FOR STATUS OF AGRICULTURAL COMMISSIONER'S APPROVAL. OTHERWISE, PLANT MATERIAL NOT CONFORMING WITH CURRENT LAWS MAY BE DESTROYED AND CIVIL ACTION ORIGINATED. ALL PLANT MATERIAL IS SUBJECT TO INSPECTION AT THE DISCRETION OF THE AGRICULTURAL COMMISSIONER'S OFFICE. ALL PLANT MATERIAL MUST BE FREE OF DISEASE.

12. NO SHEDS ARE TO BE PLANTED WITHIN 12" OF HARDSHIP, MEASURED FROM CENTER OF SHED.

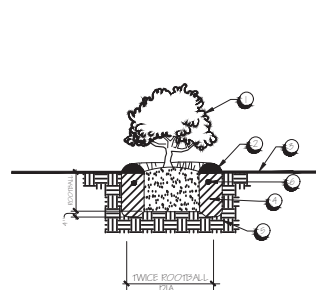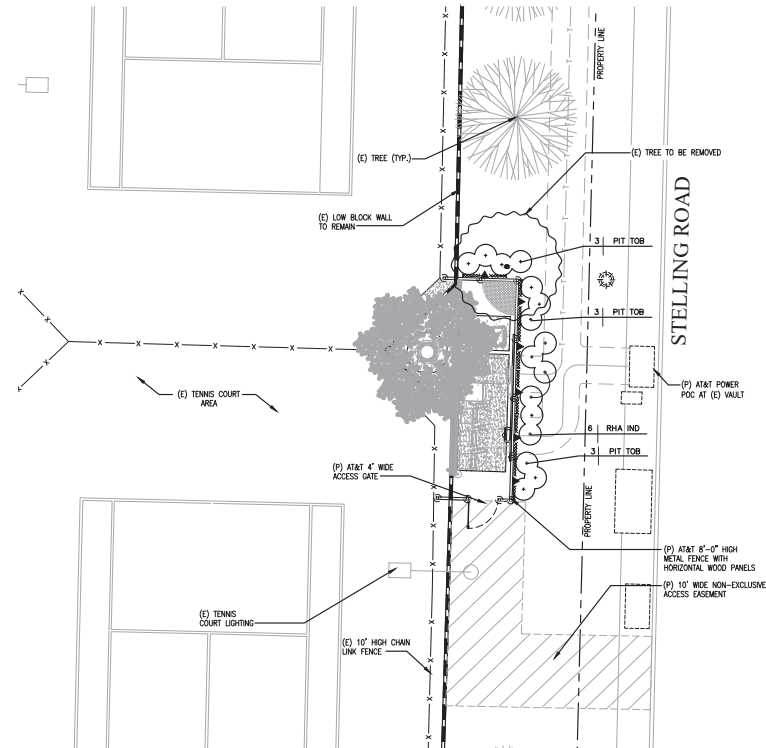

A SHRUB PLANTING
N.T.S.

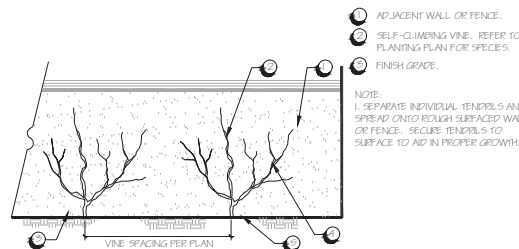

B VINE - SELF CLIMBING
SCALE: 1/4" = 1'-0"

- ① ADJACENT WALL OR FENCE.
- ② SELF-CLIMBING VINE. REFER TO PLANTING PLAN FOR SPECIES.
- ③ FINISH GRADE.

NOTE:
1. SEPARATE INDIVIDUAL TENDRILS AND
SPREAD ONTO ROUGH SURFACED WALL
OR FENCE. SECURE TENDRILS TO
SURFACE TO AID IN PROPER GROWTH.

SCALE: $1/8" = 1' - 0"$



5001 EXECUTIVE PARKWAY,
SAN RAMON, CA 94583



575 Lennon Ln #125
Walnut Creek, CA 94598

PLANS PREPARED BY:

INTELOCITY
DESIGN | BUILD | INNOVATE

1875 Coronado Ave
Signal Hill, CA 90755

A NUWAVE COMPANY

3	10/02/18	CLIENTS COMMENTS	BC
2	08/23/18	ADDITIONAL REDLINES	MM
1	08/13/18	100% ZONING DRAWINGS	MM
0	07/18/18	90% ZONING DRAWINGS	PDC
REV	DATE	DESCRIPTION	INT

CS
DG

6965 El Camino Real
Suite 105-482
Carlsbad, CA 92009
(P) 760-272-5742
(F) 760-454-3097

CS Design Group, Inc.

IT IS A VIOLATION OF LAW FOR ANY PERSON,
UNLESS THEY ARE ACTING UNDER THE DIRECTION
OF A LICENSED PROFESSIONAL ENGINEER,
TO ALTER THIS DOCUMENT.

CCL04011/CNU4011
CUPERTINO SPORTS CENTER
21111 STEVENS CREEK BLVD
CUPERTINO, CA 95014
MONOPINE/OUTDOOR

SHEET TITLE
PLANTING PLAN

SHEET NUMBER

L-3